

1

2

3

4



5

6

7

Rev	Revision note	Created by	Checked by	Approved by	Date
0	RELEASED	RR	PPN	RC	2012-MAY-29
1	SCR-1600-10A1 ROUTING REVISED	RR	PPN	RC	2012-JUN-25

DUCTING ISOMETRIC DRAWING REFERENCE		
LINE NUMBER	ISOMETRIC DWG NO.	P & ID
SCR-1600-10A1	P00099139	P00028057
PRA-1622-8A1	P00099087	P00028042

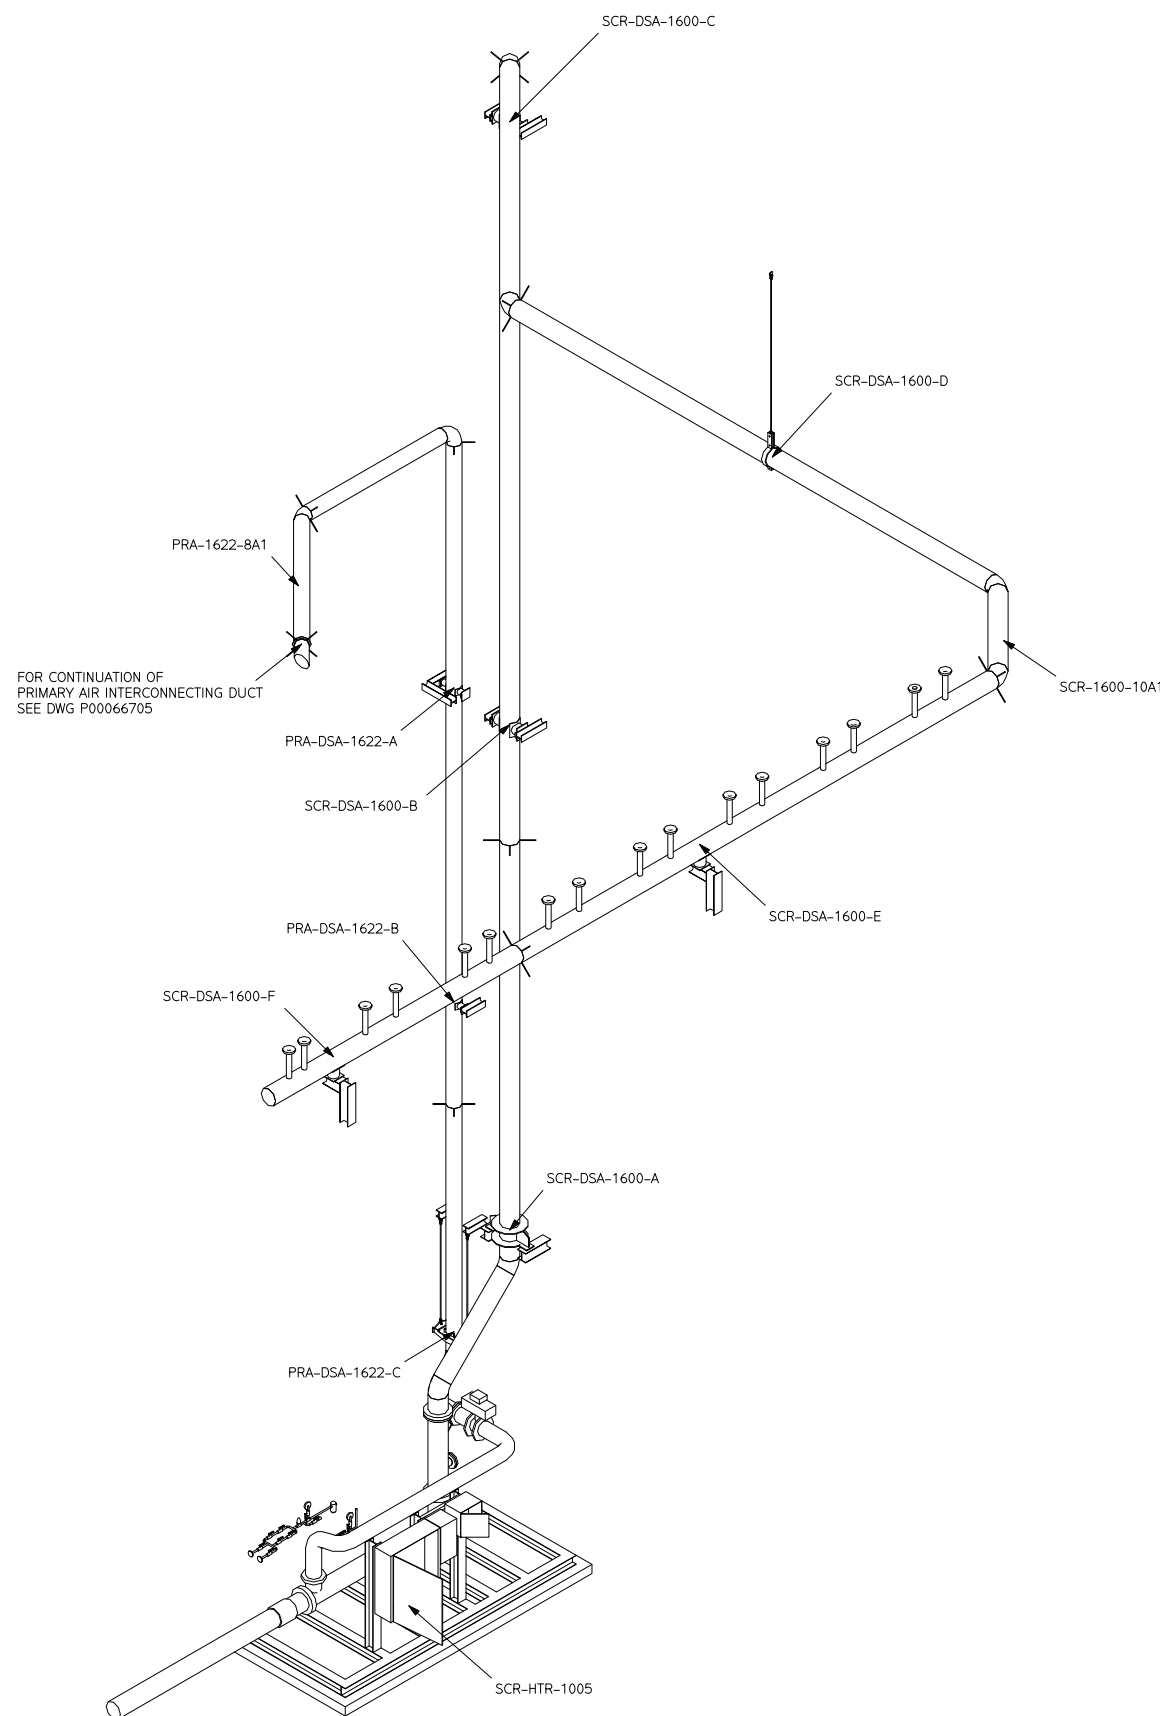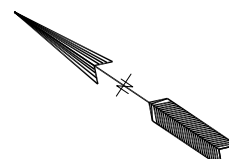

		This document is the exclusive intellectual property of Metso Corporation and/or its subsidiaries and is furnished solely for operating and maintaining the specific project. Re-use of the document for any other project or purpose is prohibited. The document or the information shall not be reproduced, copied or disclosed to a third party without prior written consent of the company.		Size D
Proj. no GRECBFB / 19002	Proj. name REC, LLC - GAINESVILLE, FL			Scale NTS
Title SYSTEM AXONOMETRIC		PRIMARY AIR TO AMMONIA VAPOURIZER GENERAL ARRANGEMENT		
Code B50210-30	Info	Doc.id. P00099135	Revision 1	
Status CERTIFIED FOR CONSTRUCTION				

1

2

3

4

5

6

7

PDMS DRAWING
DO NOT REVISE MANUALLY